


REVISIONS						
ECN#	REV	DESCRIPTION	DWN	CHKD	ENG	DATE

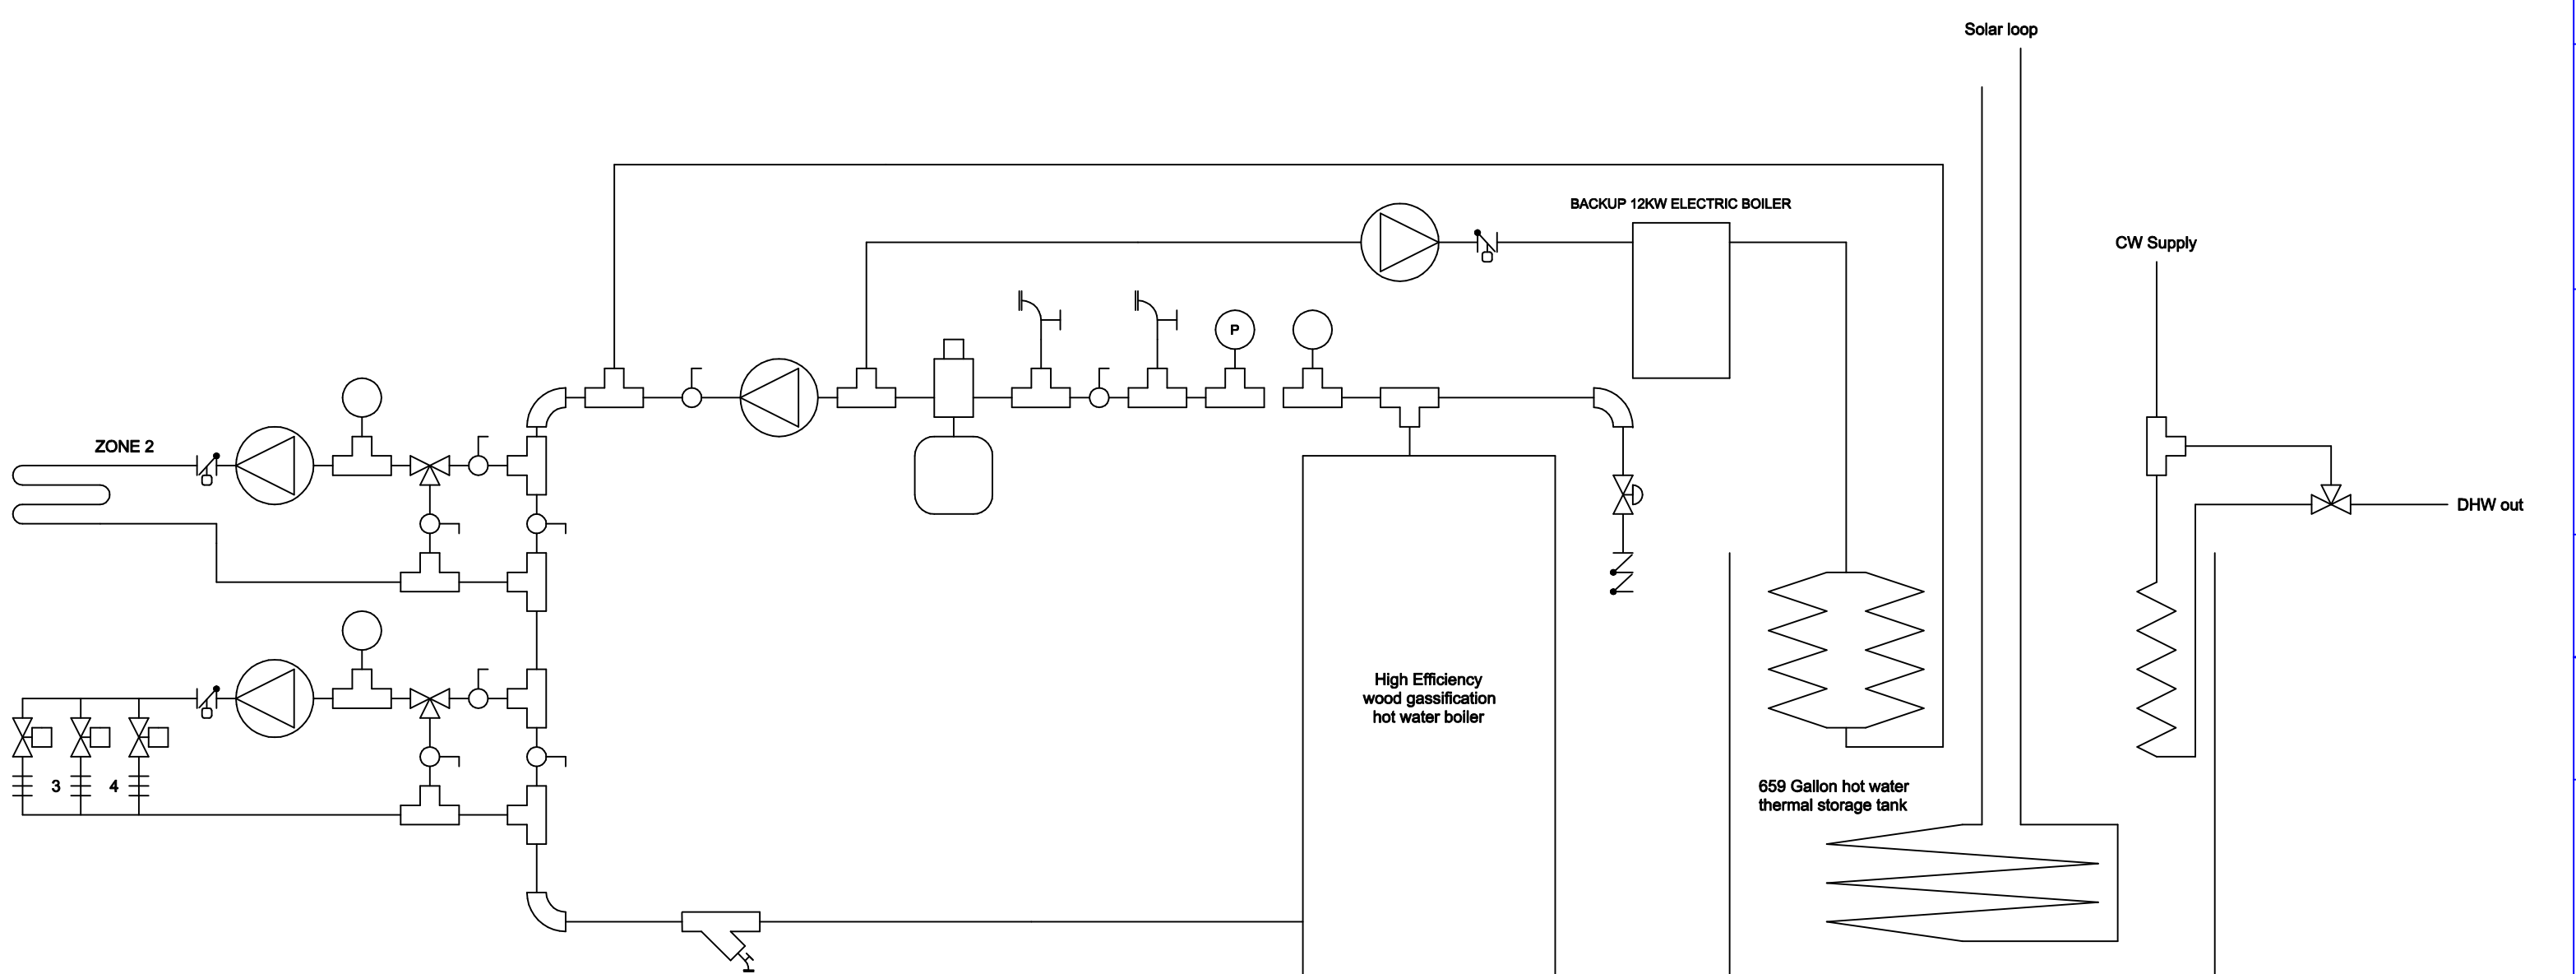

CODE IDENT
○ INDICATES ITEM NO.
◊ INDICATES LOCAL NOTE

- UNLESS OTHERWISE SPECIFIED
1. REMOVE ALL BURRS & SHARP EDGES
 2. DIMENSIONAL LIMITS APPLY AFTER FINISHING
 3. SHEAR FINISH ACCEPTABLE
 4. DIMENSIONS ARE IN INCHES
 5. TOLERANCES: .002 .010 .015 .020 .030 .040 .050 .060 .070 .080 .090 .100 .125 .150 .175 .200 .250 .300 .375 .500 .625 .750 .875 1.000 1.250 1.500 1.750 2.000 2.500 3.000 3.750 4.500 5.000 6.000 7.000 8.000 9.000 10.000

WHERE USED

PROPRIETARY INFORMATION
 THE INFORMATION CONTAINED HEREIN IS PROPRIETARY TO FOM SYSTEMS, INC. MOGADORE, OHIO. ANY REPRODUCTION, IN WHOLE OR IN PART, DISCLOSURE, OR USE OF THIS DRAWING IS EXPRESSLY PROHIBITED EXCEPT AS SPECIFIED IN WRITING BY FOM SYSTEMS, INC.

FOM Systems, Inc.
 Mogadore, Ohio USA

DESCRIPTION
**PROPOSED PIPING PLAN
 NEW GASSIFICATION BOILER**

DRAWN BY JWS	DATE 8/09
CHECKED BY	DATE
APPROVED BY	DATE

SIZE D DRAWING NUMBER

DO NOT SCALE DRAWING SCALE SHEET OF